



419 Fifth Street, Suite 2100
Defiance, OH 43512
Phone 419-782-6211
architects@beilharzinc.com

September 15, 2026

PAULDING FAMILY HEALTH CLINIC
Paulding, Ohio

C6-5091

ADDENDUM 1

This Addendum becomes a part of the Contract Documents and modifies them only to the extent herein set forth. Bidders shall acknowledge receipt of this Addendum on the Bid Form. Each bidder is responsible for distribution of information conveyed by this Addendum to its subbidders and suppliers.

Attachments: Sheets A-401, A-601 (revised)
Bid Question Log #1

ITEM NO. 1: Sheet A-401 – Enlarged Floor Plan, Interior Elevations, Accessories Schedule, Casework Schedule


Refer to attached revised Drawing for Toilet Room elevation revisions.

ITEM NO. 2: Sheet A-601 – Door Schedule and Details, Signage, Room Finish Schedule, Finish Materials


Refer to attached revised Drawing for Material and Color Schedule, and revisions to other schedules.

END OF ADDENDUM


SCALE: 3/32"=1'-0"
SCALE: 1/8"=1'-0"
SCALE: 3/16"=1'-0"
SCALE: 1/16"=1'-0"
SCALE: 1/12"=1'-0"
SCALE: 3/8"=1'-0"
SCALE: 1/2"=1'-0"
SCALE: 1 1/2"=1'-0"
SCALE: 1 1/2"=1'-0"
SCALE: 1 1/2"=1'-0"
SCALE: 1 1/2"=1'-0"
SCALE: 1 1/2"=1'-0"
SCALE: 1 1/2"=1'-0"
SCALE: 1 1/2"=1'-0"

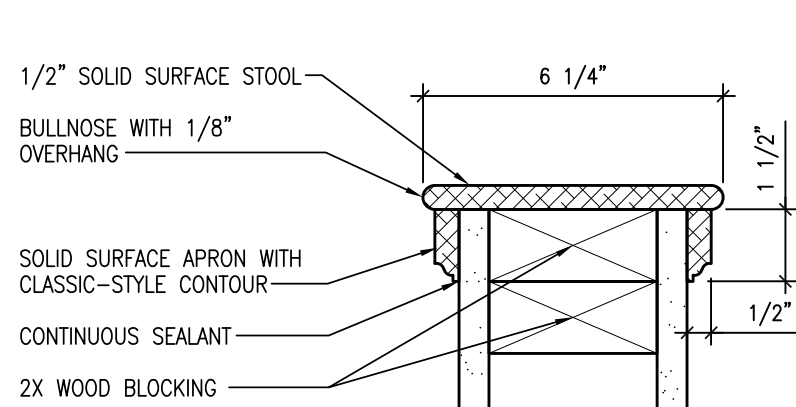


9 WALL CAP SECTION
A-401 3/8"=1'-0"

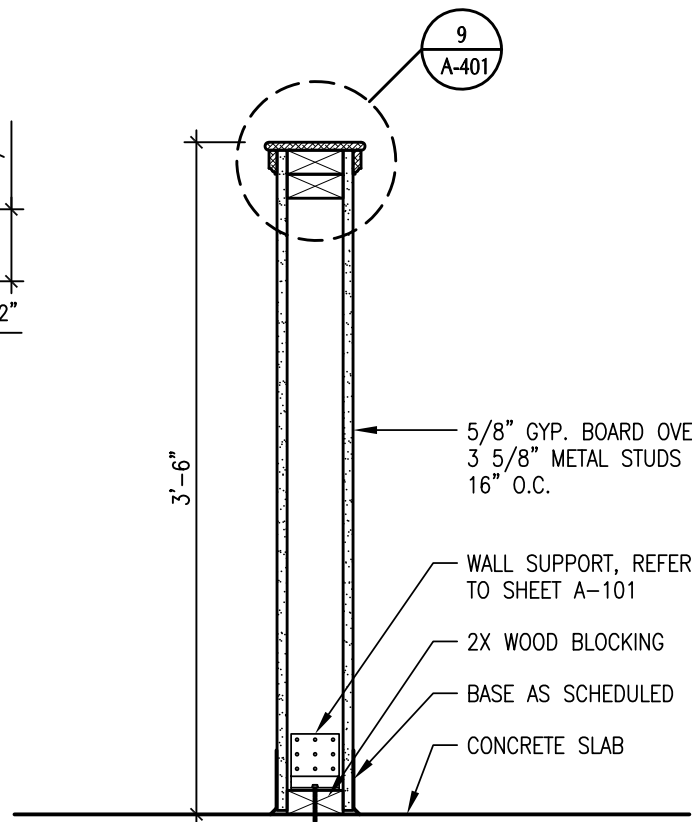


8 WALL SECTION
A-101 1"=1'-0"

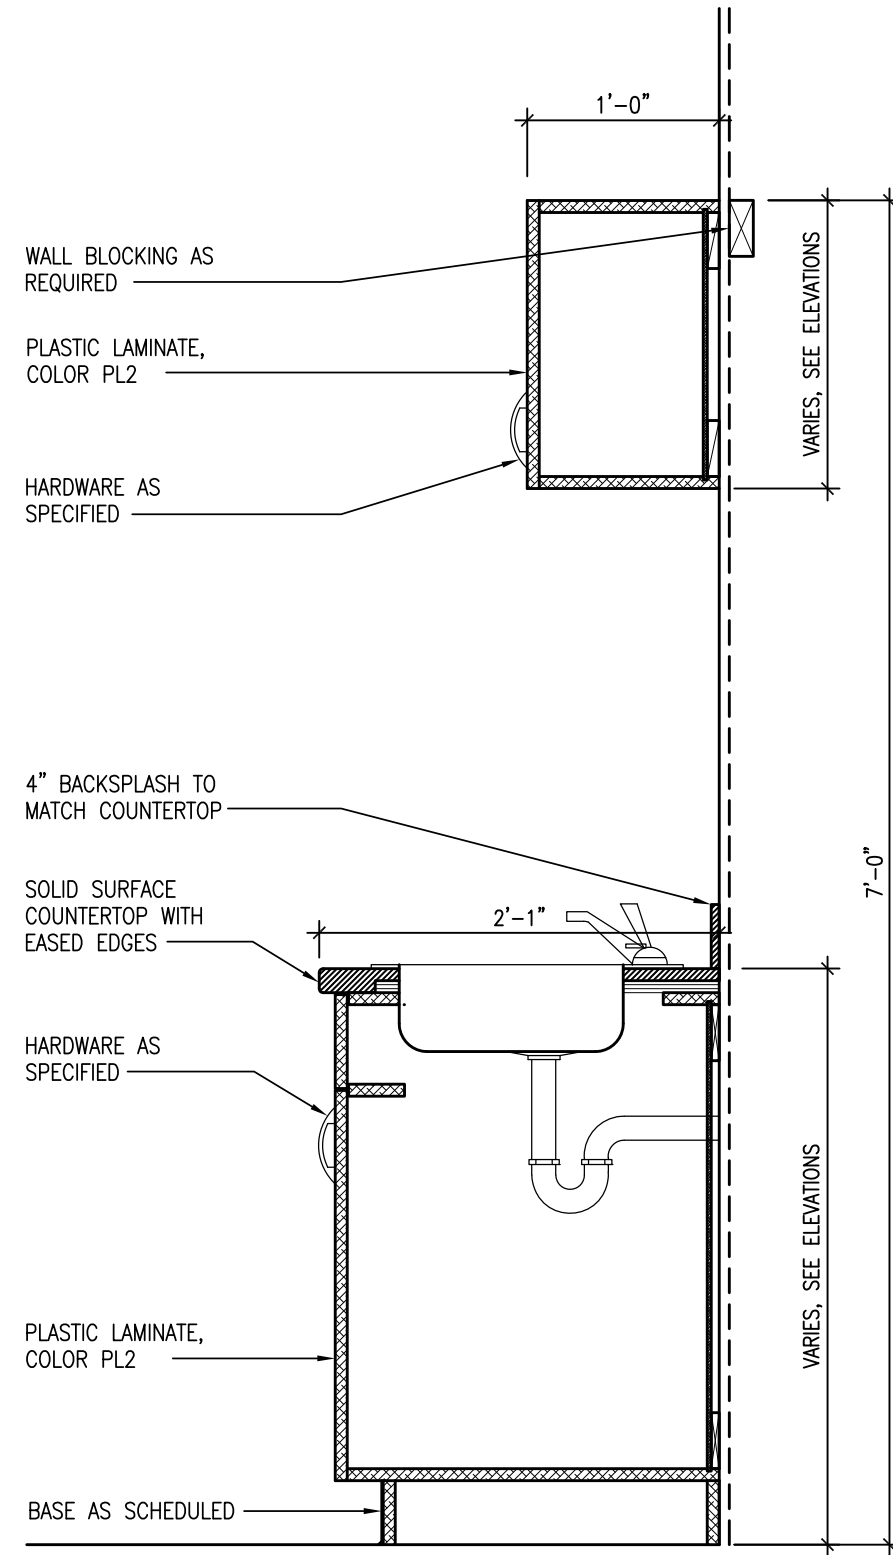


7 SINK CASEWORK SECTION
A-401 1"=1'-0"

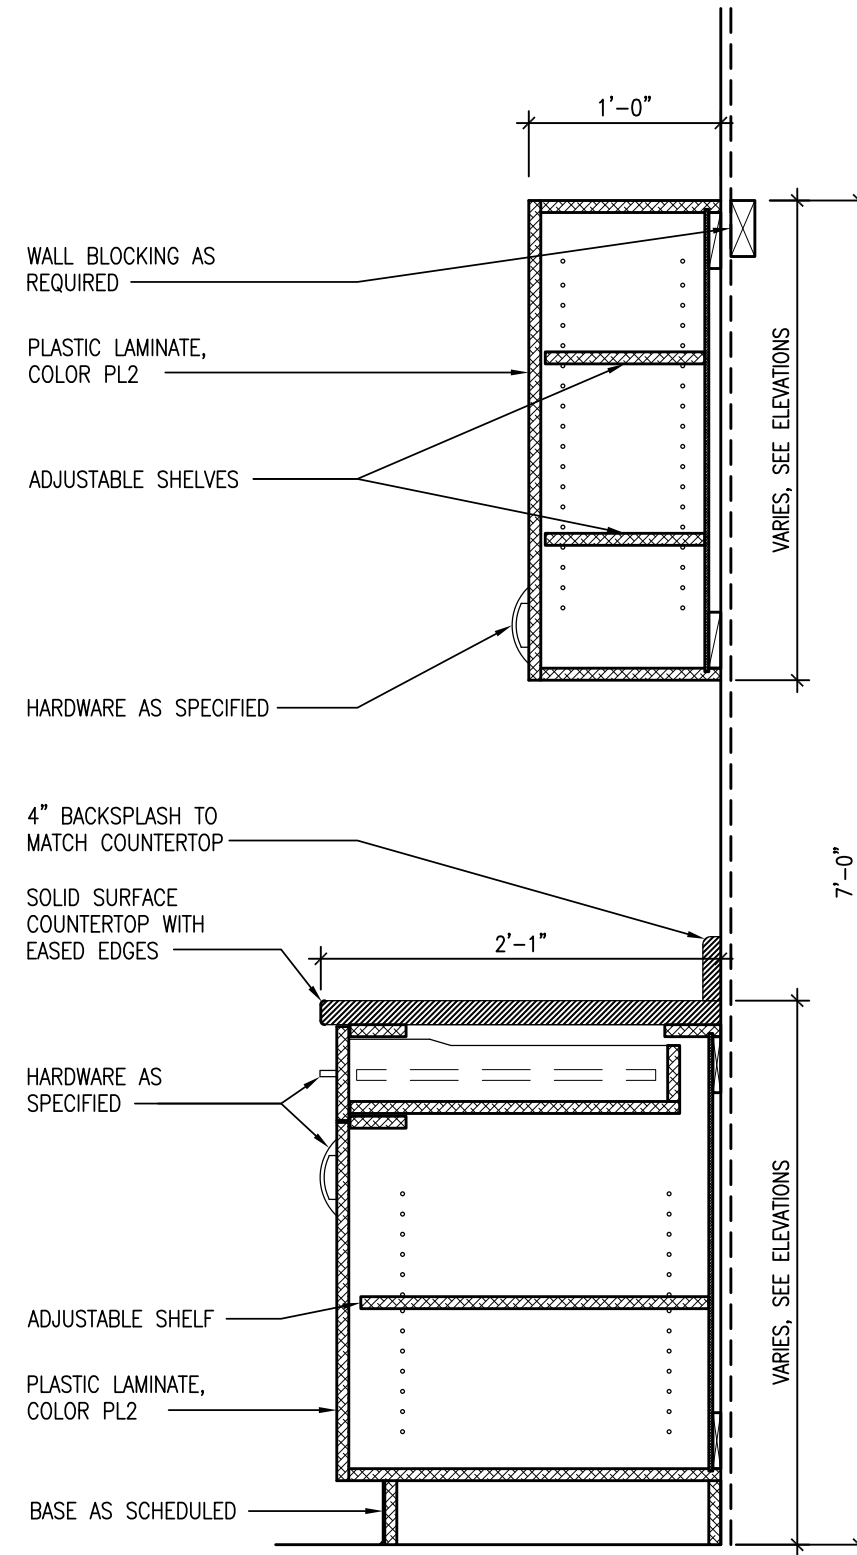


6 TYPICAL CASEWORK SECTION
A-401 1"=1'-0"

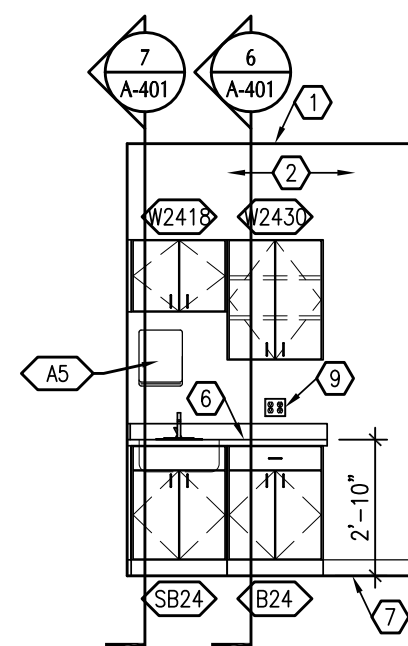




5 TYPICAL EXAM ROOM
A-101 1/4"=1'-0"

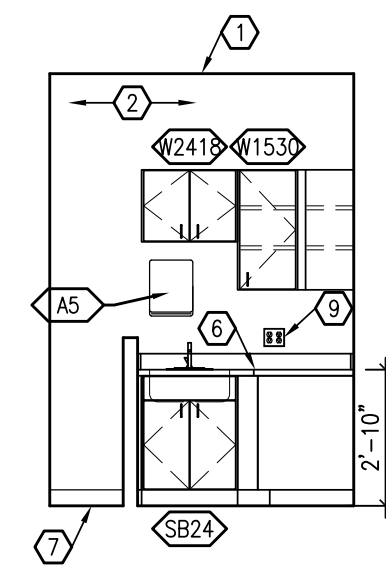


4B LAB STATION 104
A-101 1/4"=1'-0"

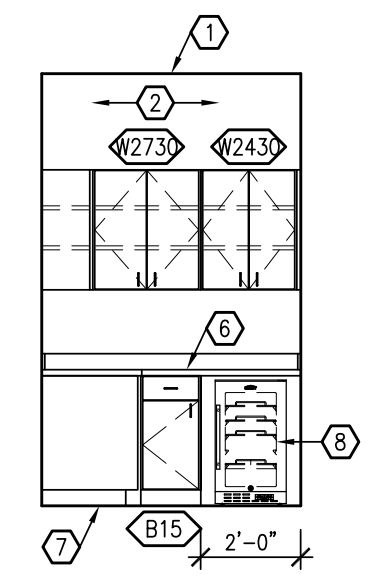


4A LAB STATION 104
A-101 1/4"=1'-0"

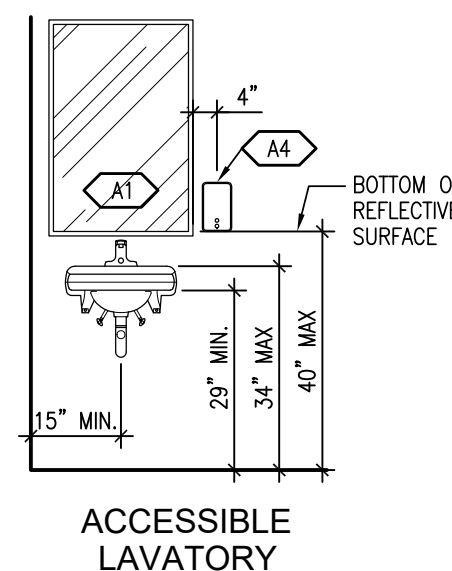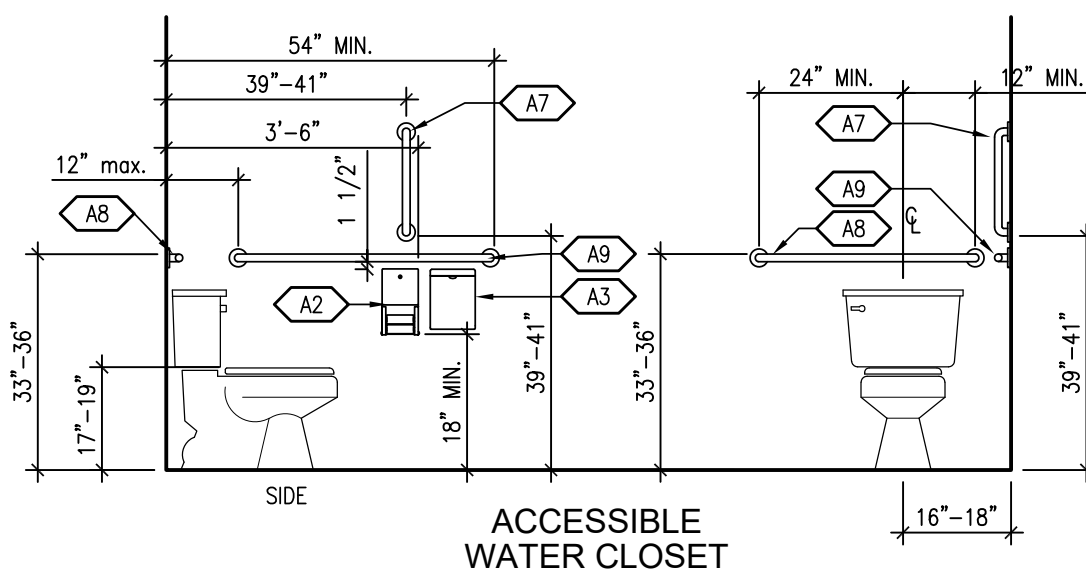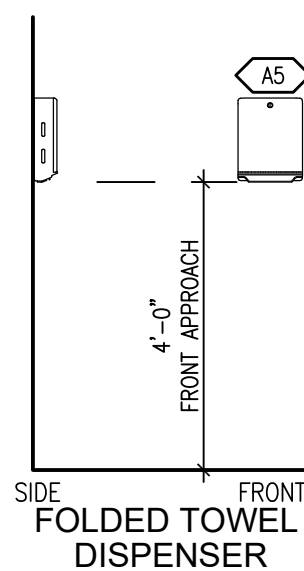


3 FIXTURE & ACCESSORY
MOUNTING HEIGHTS
A-401 3/8"=1'-0"

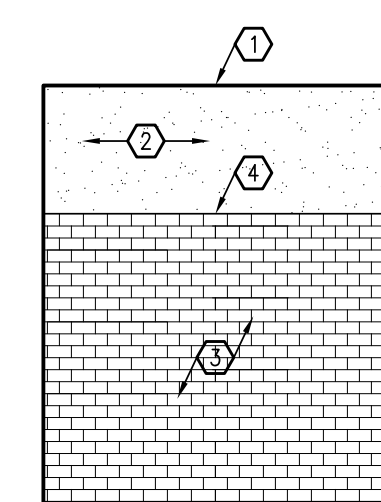


2D TOILET ROOM 109
A-401 1/4"=1'-0"

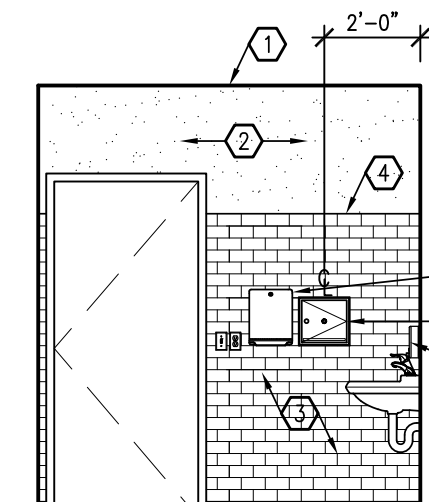


2C TOILET ROOM 109
A-401 1/4"=1'-0"

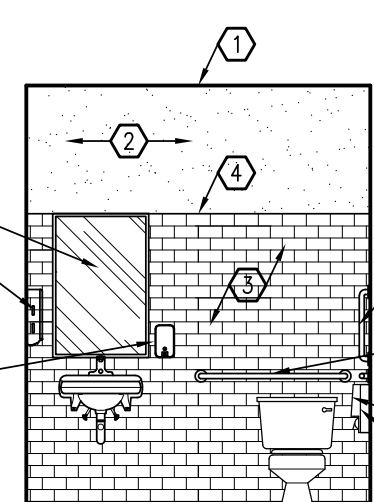

2B TOILET ROOM 109
A-401 1/4"=1'-0"

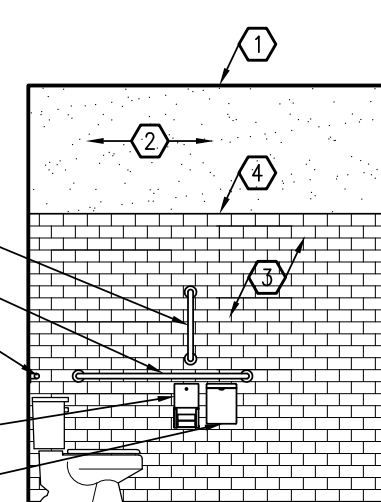

2A TOILET ROOM 109
A-401 1/4"=1'-0"

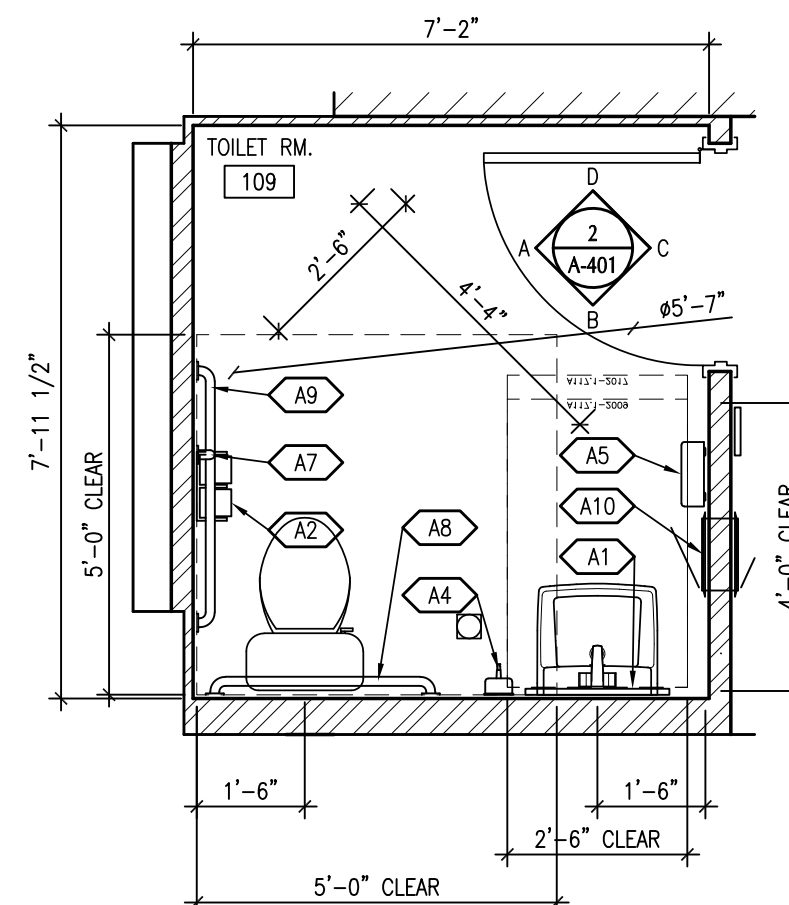

1 ENLARGED TOILET ROOM
A-101 3/8"=1'-0"

CASEWORK SCHEDULE						
MARK	DESCRIPTION	SIZE			SHEET A-401 DETAIL	NOTES
		W	D	H		
B24	BASE CABINET	24	24	34	6	
B15	BASE CABINET	15	24	34	6	
SB24	BASE CABINET	15	24	34	7	
W2730	WALL CABINET	27	14	30	6	
W2430	WALL CABINET	24	14	30	6	
W1530	WALL CABINET	15	14	30	6	
W2418	WALL CABINET	24	14	18	7	

ACCESSORIES SCHEDULE										
MARK	ROOM									
		A1	A2	A3	A4	A5	A6	A7	A8	A9
109	Toilet Room	•	•	•	•	•	•	•	•	•
NOTES		A	A	A	A	A	A	A	A	B,C
NOTES LEGEND										
A Surface mounted, provide solid blocking (framed walls) for attachment										
B Recessed mounted. Refer to manufacturer's specifications for blocking requirements.										
C See this sheet for fixture and accessory mounting heights.										


- GENERAL CASEWORK NOTES
- FIELD VERIFY DIMENSIONS PRIOR TO FABRICATION
 - COUNTERTOP FABRICATOR SHALL OBTAIN FROM THE PLUMBING SUPPLIER A CUTOUT TEMPLATE FOR EACH SINK USED AND VERIFY CLEARANCES PRIOR TO FABRICATION OF UNITS. FABRICATOR SHALL REWORK COUNTERTOPS IF VERIFICATION PROCESS IS NOT COMPLETELY PERFORMED.
 - EXPOSED CABINET ENDS, SIDES AND BACKS SHALL HAVE FINISHED PANELS TO MATCH CABINET FRONT.
 - INSTALL EQUIPMENT PER MANUFACTURER'S INSTRUCTIONS AND AS REQUIRED BY APPLICABLE REGULATIONS, STANDARDS. COORDINATE EQUIPMENT LOCATIONS BETWEEN TRADES. PROVIDE SOLID BLOCKING AS REQUIRED BY MANUFACTURER.
 - PROVIDE MATCHING FILLER PANELS WHERE CABINETS ABUT WALL AND WHERE NECESSARY
 - PLASTIC LAMINATE COUNTERTOPS SHALL HAVE 180° WRAP EDGES, UNLESS NOTED OTHERWISE
 - AT UPPER CABINETS, PROVIDE TOPS ON FILLER PANELS.

GENERAL MOUNTING HEIGHT NOTES

- SEE PLUMBING FIXTURE SCHEDULE AND ACCESSORY SCHEDULE FOR FIXTURES AND ACCESSORIES USED
- VERIFY HEIGHTS OF ACCESSORIES WHERE LOCATED ABOVE COUNTERTOPS

KEYNOTE LEGEND

- CEILING AS SCHEDULED
- GYPSUM BOARD, PAINT
- FRP
- FRP EDGE TRIM MOLDING CHANNEL
- NOT USED
- P. LAMINATE COUNTERTOP WITH 4" BACKSPLASH, RETURN AT WALL END
- BASE AS SCHEDULED
- EQUIPMENT/APPLIANCE BY OWNER
- ELECTRICAL DEVICE OR FIXTURE, REFER TO ELECTRICAL

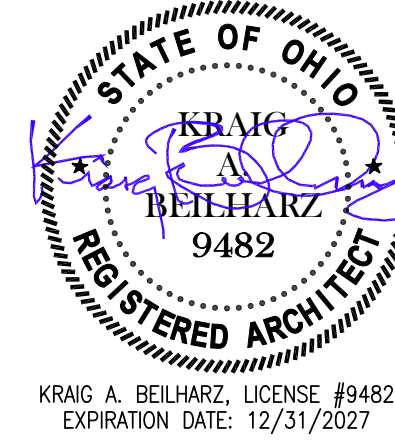

ISSUE DATE	
1	08-11-2026 REVIEW SET
2	08-17-2026 PERMIT SET
3	09-15-2026

© 2026 BEILHARZ ARCHITECTS, INC.
THE CONTENT OF THIS DRAWING IS NOT INTENDED TO BE SUBMITTED FOR USE OR REUSE BY INDIVIDUALS, COMPANIES, CORPORATIONS, OR OTHER ENTITIES FOR ANY PURPOSE OTHER THAN THE INTENDED PURPOSE OF THIS DOCUMENT, NOR FOR USE ON ANY OTHER PROJECT. ANY REUSE OR REPRODUCTION WITHOUT WRITTEN VERIFICATION AND ADAPTION BY THE ARCHITECT FOR THE SPECIFIC PURPOSE INTENDED SHALL BE AT THE USER'S SOLE RISK AND WITHOUT LIABILITY OR LEGAL EXPOSURE TO THE ARCHITECT.

PAULDING EVSD HEALTH CLINIC
FAMILY HEALTH CARE OF NORTHWEST OHIO, INC.
405 NORTH WATER STREET
PAULDING, OHIO 45879

ENLARGED FLOOR PLAN
INTERIOR ELEVATIONS
ACCESSORIES SCHEDULE
CASEWORK SCHEDULE

PROJECT: C6-5091


DRAWN BY: SB

CHECKED BY: KB

SHEET

A-401

SCALE: 3/32"=1'-0"
SCALE: 1/8"=1'-0"
SCALE: 3/16"=1'-0"
SCALE: 1/4"=1'-0"
SCALE: 3/8"=1'-0"
SCALE: 1/2"=1'-0"
SCALE: 1/2"=1'-0"
SCALE: 1 1/2"=1'-0"
SCALE: 1 1/2"=1'-0"



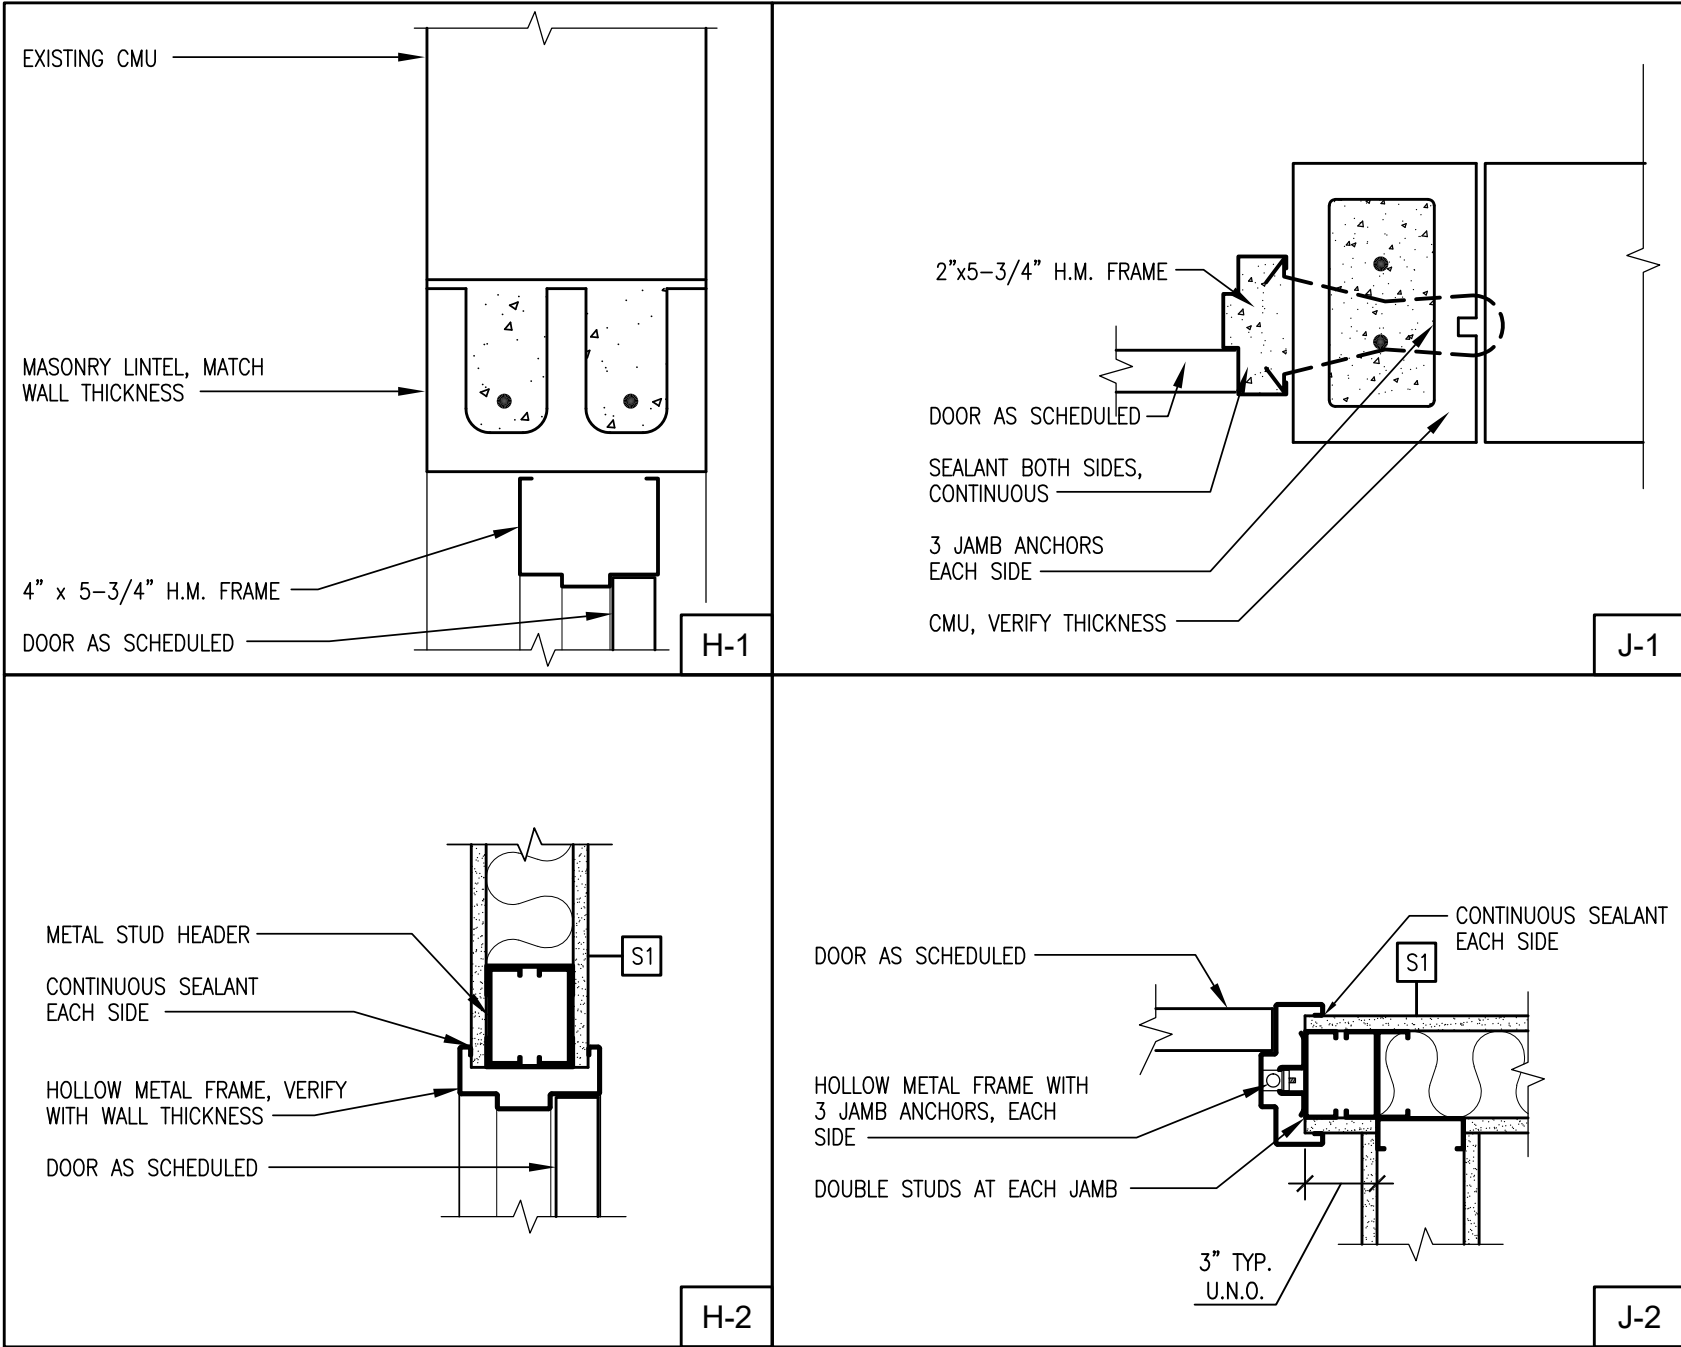


MATERIAL AND COLOR SCHEDULE						
ITEM	DESCRIPTION	MFR	PRODUCT	SIZE	COLOR	NOTES
FLOORING						
102	LVT Luxury Vinyl Tile	Shaw Contract	Cast 2.5mm	24"x34"	To Be Selected	
BASE						
RC	Rubber Cove Base	Roppe	Pinnacle	4.5"	To Be Selected	
MISC						
FRP	FRP Panels, 4x8' Wood Doors	Marlite, Symmetrix	3"x6" Subway Match Existing		White, Grey grout lines	
	Electrical Devices				White	
	Electrical Cover Plates				White	
PAINT						
HM	Doors/Frames, Interior Walls	Sherwin Williams			Match Existing	
		Sherwin Williams			Match Existing	
CASEWORK						
PL1	Casework	Wilsonart			To Be Selected	
PL2	Countertops	Wilsonart			To Be Selected	
SS	Solid Surface Countertops	Corian			To Be Selected, Grade 1	
	Casework Hardware				Satin Chrome	

ROOM FINISH SCHEDULE														
ROOM	FLOOR	BASE	WALLS								CEILING		HEIGHT	
			MATL	N	FIN	MATL	S	FIN	MATL	E	FIN	MATL	W	FIN
101 Waiting	X	X	X	X	X	X	X	X	X	X	X	X	X	-
102 Waiting	LVT	RC	G	P1	G	P1	G	P1	G	P1	G	P1	SA4	- 9'-0"
103 Reception/Nurse Station	LVT	RC	G	P1	G	P1	G	P1	G	P1	G	P1	SA4	- 9'-0"
104 Lab Station	LVT	RC	G	P1	G	P1	G	P1	G	P1	G	P1	SA4	- 9'-0"
105 Exam Room 1	LVT	RC	G	P1	G	P1	G	P1	G	P1	G	P1	SA4	- 9'-0"
106 Exam Room 2	LVT	RC	G	P1	G	P1	G	P1	G	P1	G	P1	SA4	- 9'-0"
107 Exam Room 3	LVT	RC	G	P1	G	P1	G	P1	G	P1	G	P1	SA4	- 9'-0"
108 Provider Office	LVT	RC	G	P1	G	P1	G	P1	G	P1	G	P1	SA4	- 9'-0"
109 Toilet Room	LVT	RC	G	FRP	G	FRP	G	FRP	G	FRP	G	P1	SA4	- 9'-0"
FLOOR MATERIAL LEGEND			WALL MATERIAL LEGEND			FINISH LEGEND								
X	Existing to remain		X	Existing to remain		X	Existing to remain							
LVT	Luxury Vinyl Tile		G	Gypsum board		P1	Paint, Eggshell							
						FRP	FRP panels							
BASE MATERIAL LEGEND			CEILING MATERIAL LEGEND											
X	Existing to remain		X	Existing to remain										
RC	Rubber cove		SA4	Susp. acoust. tile, 2x4										

DOOR SCHEDULE																			
MARK				DOOR				LOUVER		FRAME		FIRE		HDW	SIGN		NOTES		
	SIZE			MATL	ELEV	GLAZING				DETAIL		RATING	SET	TYPE	TEXT				
	W	H	THK			TYPE	W	H	TYPE	W	H					HEAD		JAMB	
101	3'-0"	7'-0"	1-3/4"	WD	B	A	24"	33"		HM	H-1	J-1		1			2		
105	3'-0"	7'-0"	1-3/4"	WD	A					HM	H-2	J-2		2	B	ROOM NAME	4		
106	3'-0"	7'-0"	1-3/4"	WD	A					HM	H-2	J-2		2	B	ROOM NAME	4		
107	3'-0"	7'-0"	1-3/4"	WD	A					HM	H-2	J-2		2	B	ROOM NAME	4		
108	3'-0"	7'-0"	1-3/4"	WD	A					HM	H-2	J-2		2	B	ROOM NAME	4		
109	3'-0"	7'-0"	1-3/4"	WD	A					HM	H-2	J-2		3	A	RESTROOM	3		
MATERIAL LEGEND				GLAZING TYPE LEGEND				LOUVER TYPE LEGEND				NOTES LEGEND							
HM	Hollow metal				A	1/4" tempered				A	Fixed V blade			1	Insulated core door				
WD	Solid core wood				B	1/4" wire glass				B	Operable Z blade			2	4" frame head				
AL	Aluminum				C	1" insul. tempered					w/ fusible link			3	See sign detail				
X	Existing to remain													4	Verify with Owner. See sign detail				
														5					
														6					

DOOR HARDWARE SCHEDULE									
FUNCTION	SET			MFR.	BASIS OF DESIGN		FINISH	NOTES	
	1	2	3		MODEL	LEVER			
Butt Hinges	3	3	3	McKinney	TA2714 4.5"x4.5"		26D		
Exit Device, Rim	■			Sargent	16-8804		26D		
Push Bar				Rockwood	27		26D		
Pull	■			Rockwood	BF157A		26D		
Cylindrical Lock, Privacy			■	Accentra	YPL02	LL	26D		
Cylindrical Lock, Office			■	Sargent	10XG05	LL	26D		
Closer, Parallel Stop Arm, Push Side	■			Sargent	351-CPS		689		
Wall Stop, Concave		■	■	Rockwood	409		32D		
Kickplate, 34"x10"		■	■	Rockwood	K1050		32D		
NOTES LEGEND									
1	Coordinate number and size of wires with security system provider								

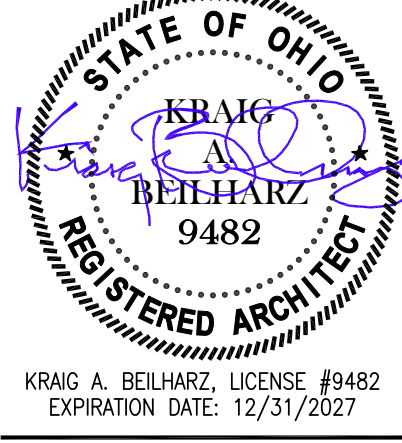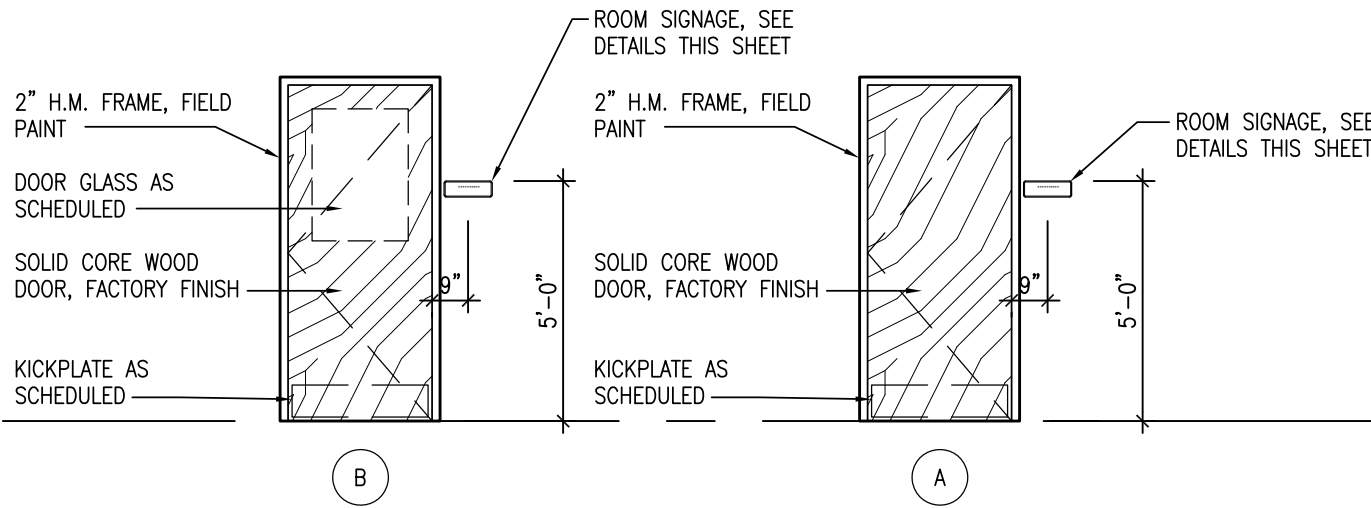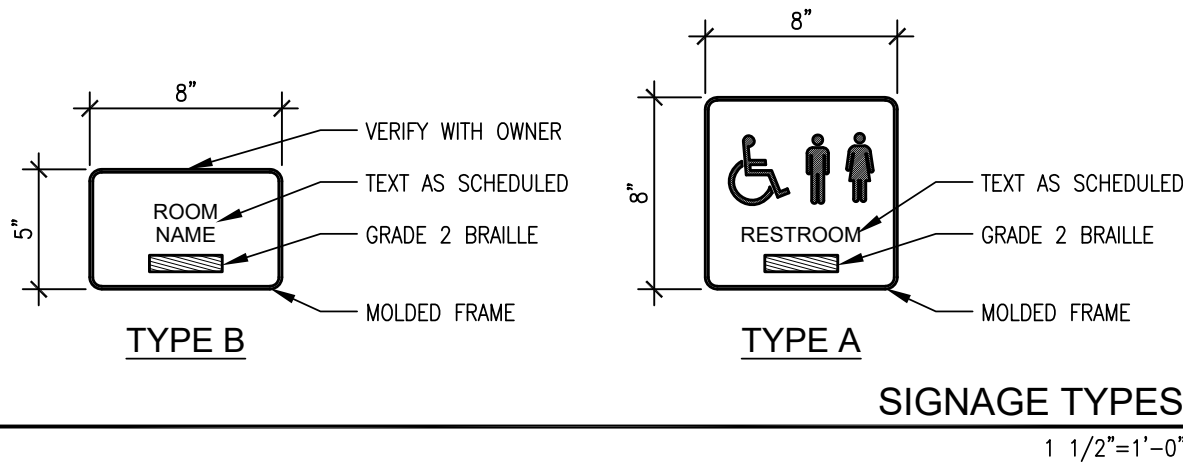

ISSUE DATE	
1	08-11-2026 REVIEW SET
2	08-17-2026 PERMIT SET
3	09-15-2026

© 2026 BEILHARZ ARCHITECTS, INC.
THE CONTENT OF THIS DRAWING IS NOT INTENDED TO BE SUBMITTED FOR USE OR REUSE BY INDIVIDUALS, COMPANIES, CORPORATIONS, OR OTHER ENTITIES FOR ANY PURPOSE OTHER THAN THE INTENDED PURPOSE OF THIS DOCUMENT, NOR FOR USE ON ANY OTHER PROJECT. ANY REUSE OR REPRODUCTION WITHOUT WRITTEN VERIFICATION AND APPROVAL BY THE ARCHITECT FOR THE SPECIFIC PURPOSE INTENDED SHALL BE AT THE USER'S SOLE RISK AND WITHOUT LIABILITY OR LEGAL EXPOSURE TO THE ARCHITECT.

PAULDING EVSD HEALTH CLINIC
FAMILY HEALTH CARE OF NORTHWEST OHIO, INC.
405 NORTH WATER STREET
PAULDING, OHIO 45879

DOOR SCHEDULE AND DETAILS, SIGNAGE, ROOM FINISH SCHEDULE, FINISH MATERIALS

PROJECT: C6-5091
DRAWN BY: SB
CHECKED BY: KB
SHEET



419 Fifth Street, Suite 2100
Defiance, OH 43512
Phone 419-782-6211
architects@beilharzinc.com

September 15, 2026

PAULDING FAMILY HEALTH CLINIC
Paulding, Ohio

C6-5091

BID QUESTION LOG #1

The following questions and answers are distributed for supplemental information and clarification, and are not part of the Contract Documents. Questions answered by Addendum items are not necessarily repeated in this document.

- Q1. Could you please confirm what key system Paulding Schools currently uses for their doors and locksets?
- A. The lockset manufacturer and keying is Sargent. Extend the existing keying system and masterkeying.

END OF BID QUESTION LOG #1